


SCALE: 1"=700'

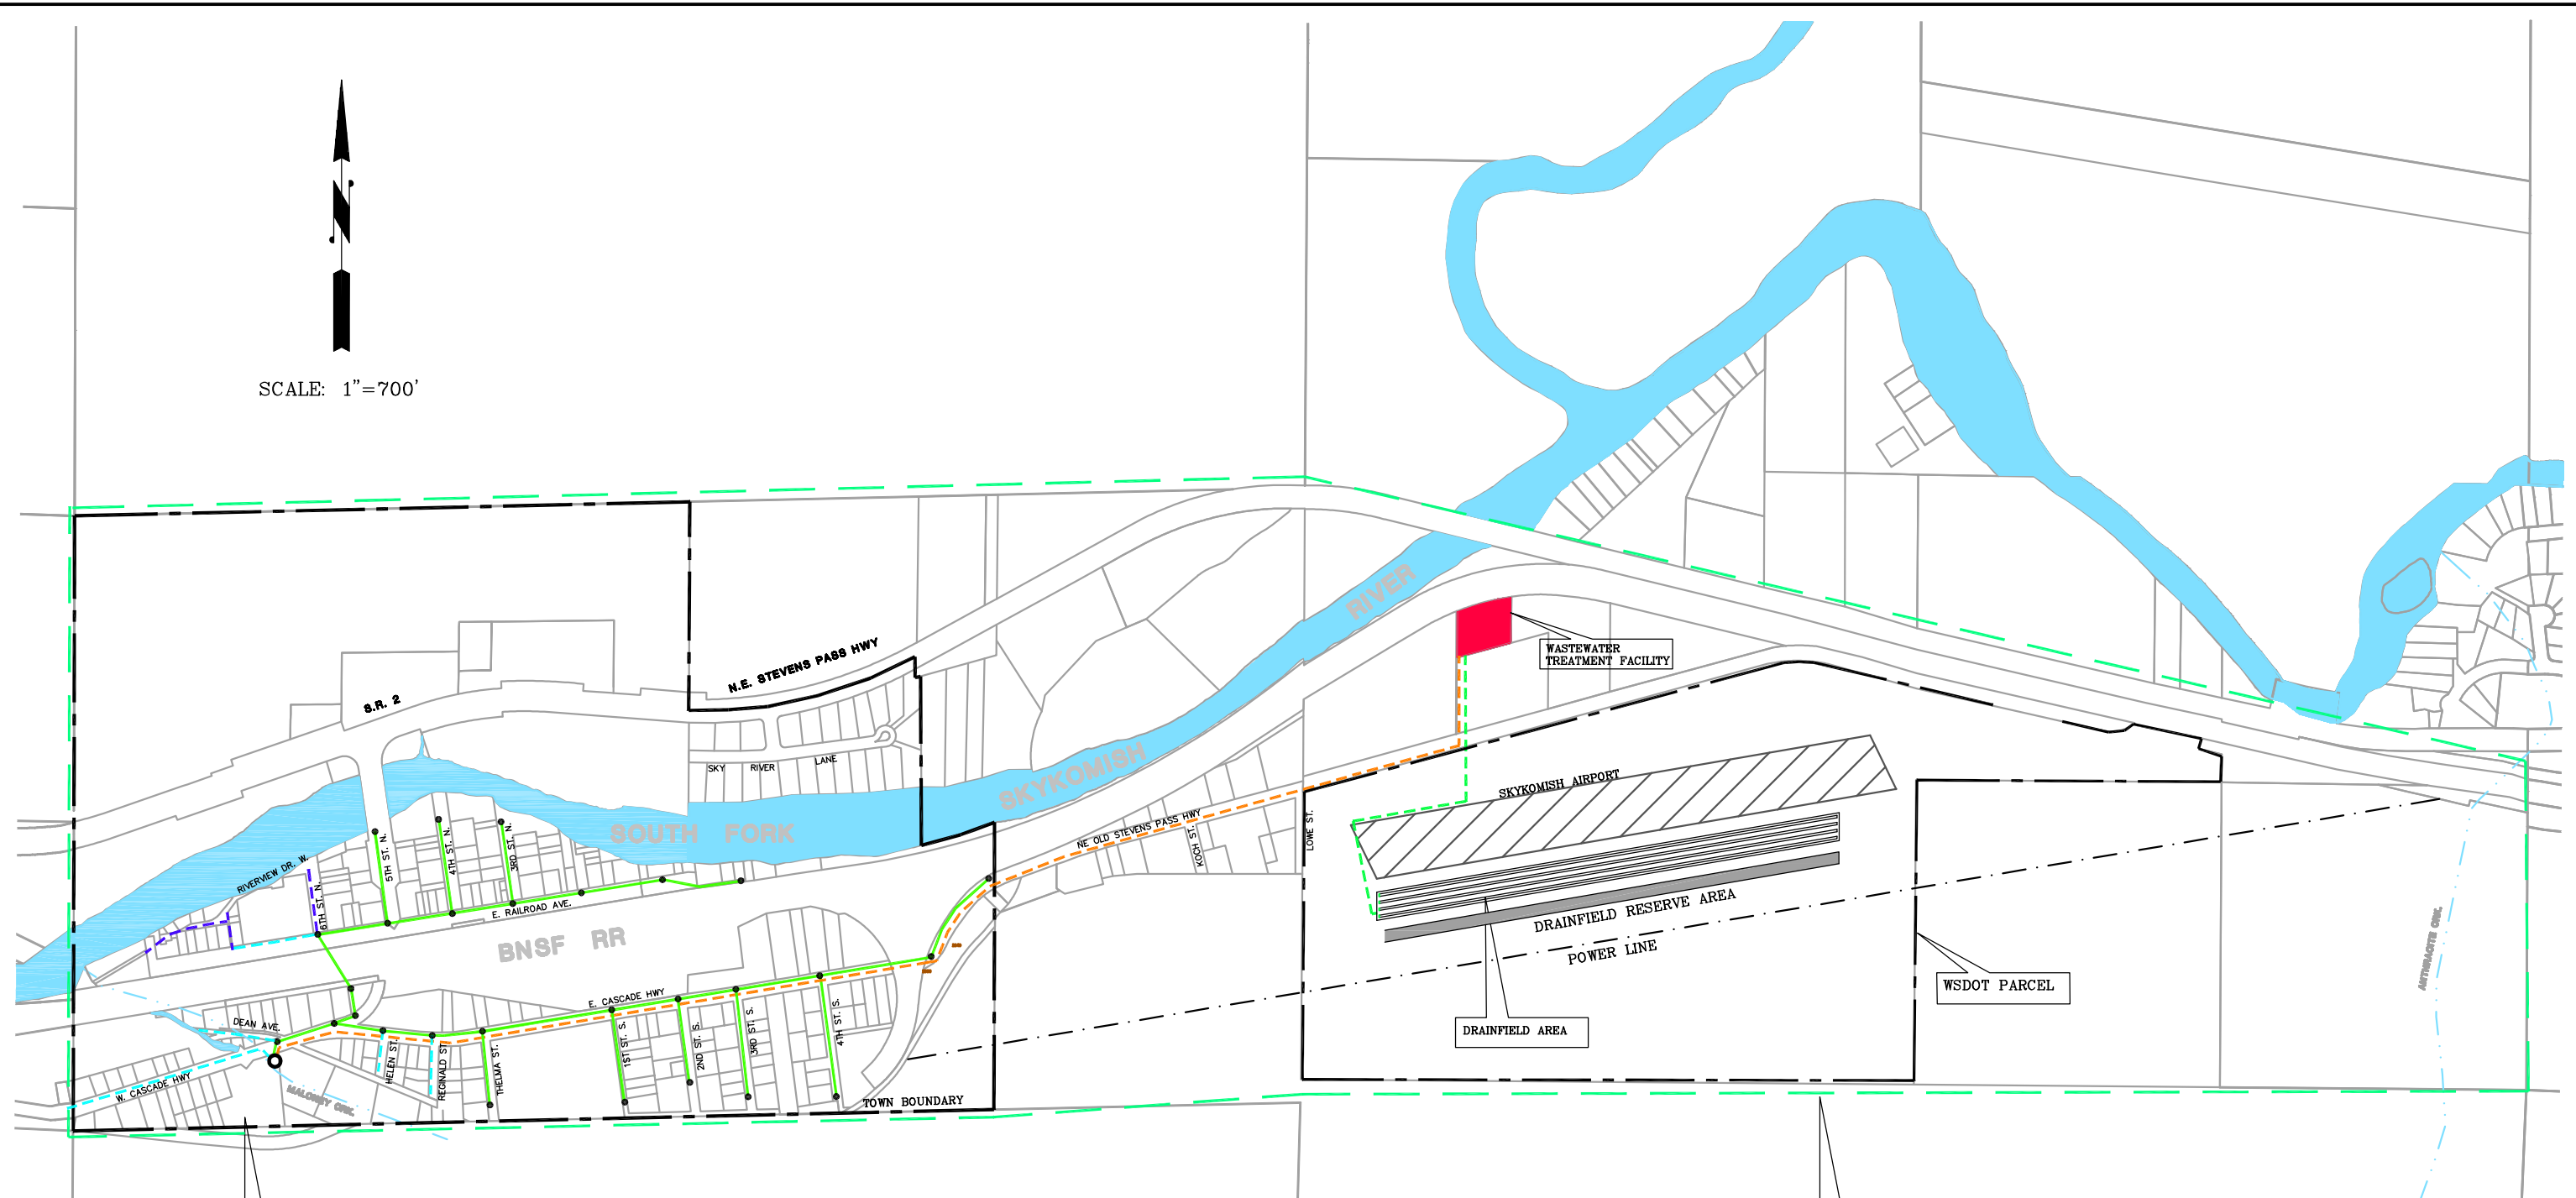

- LEGEND:**
- SKYKOMISH TOWN LIMITS
 - 4" GRAVITY SEWER
 - - - 2" PRESSURE SEWER
 - - - 3" PRESSURE SEWER
 - - - 4" FORCE MAIN
 - - - 3" FORCE MAIN
 - COMMUNITY LIFT STATION
 - VALVE MANHOLE / CLEANOUT

STEG/STEP SEWER COLLECTION SYSTEM

PLANNING AREA

TOWN OF SKYKOMISH
 SEWER FACILITIES PLAN
 FIGURE E-2
 PROPOSED SITE PLAN



Gray & Osborne, Inc.
CONSULTING ENGINEERS